

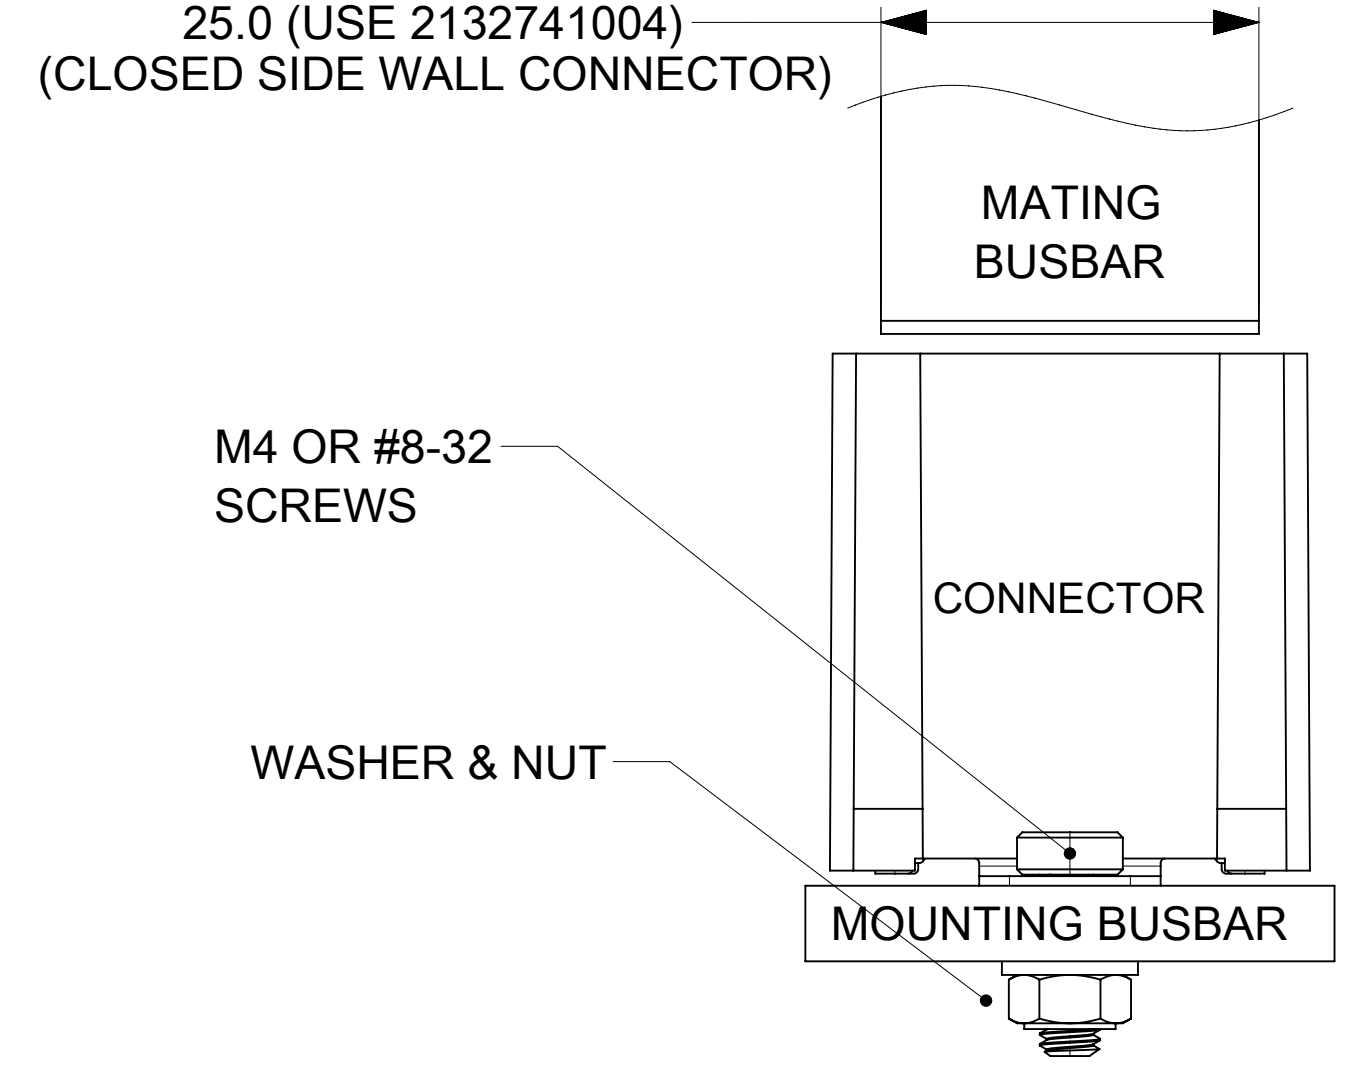
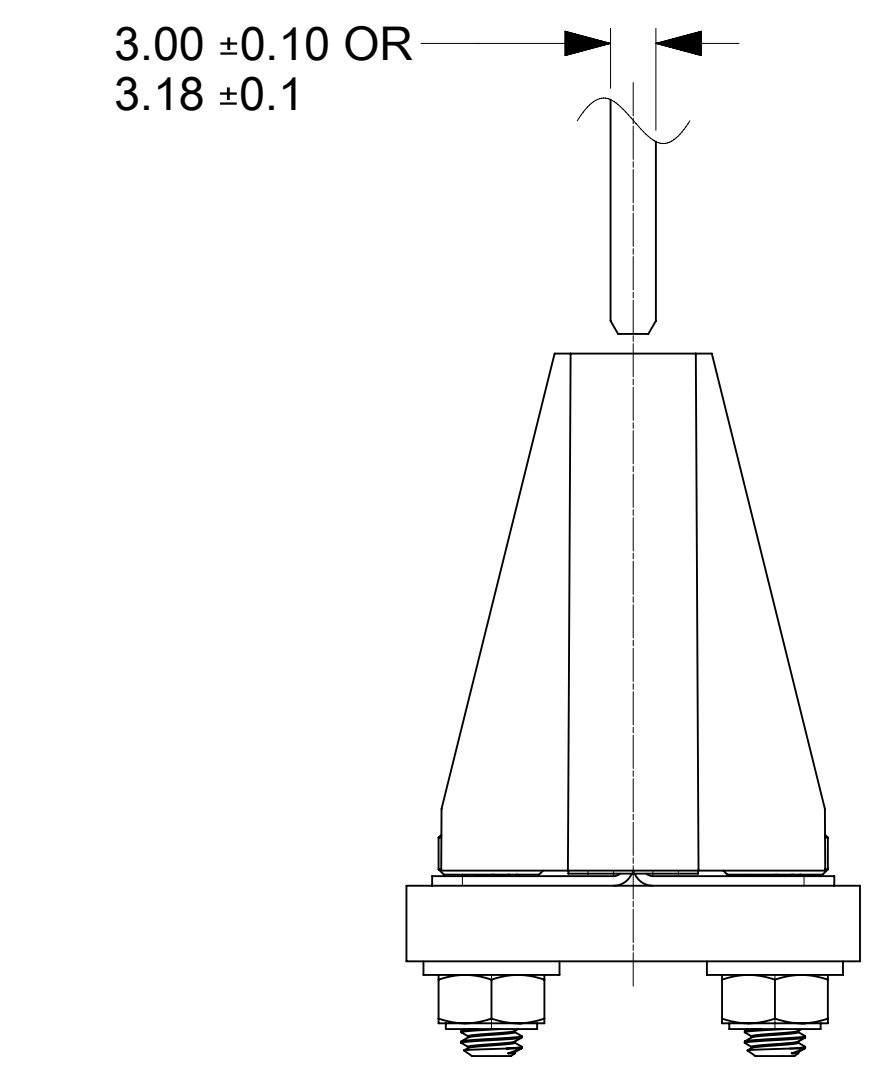
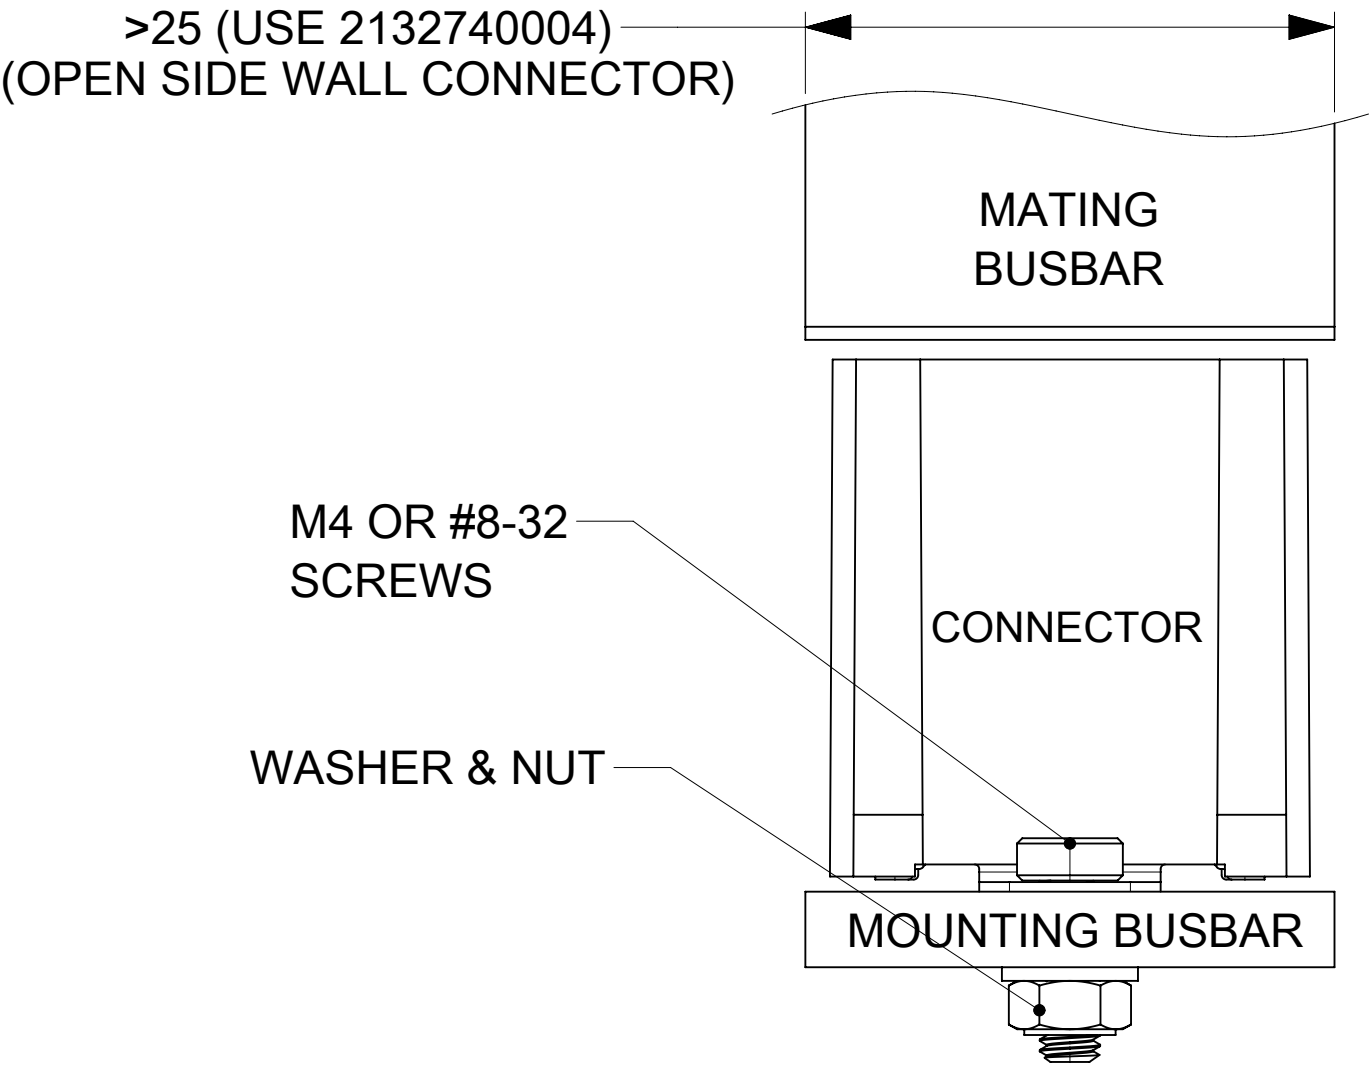


PART NUMBER	DESCRIPTION	NOTE
2132740004	OPEN SIDE WALL (SILVER)	
2132741004	CLOSED SIDE WALL (SILVER)	


PART NUMBER	DESCRIPTION	NOTE
2132740104	OPEN SIDE WALL (TIN)	
2132741104	CLOSED SIDE WALL (TIN)	

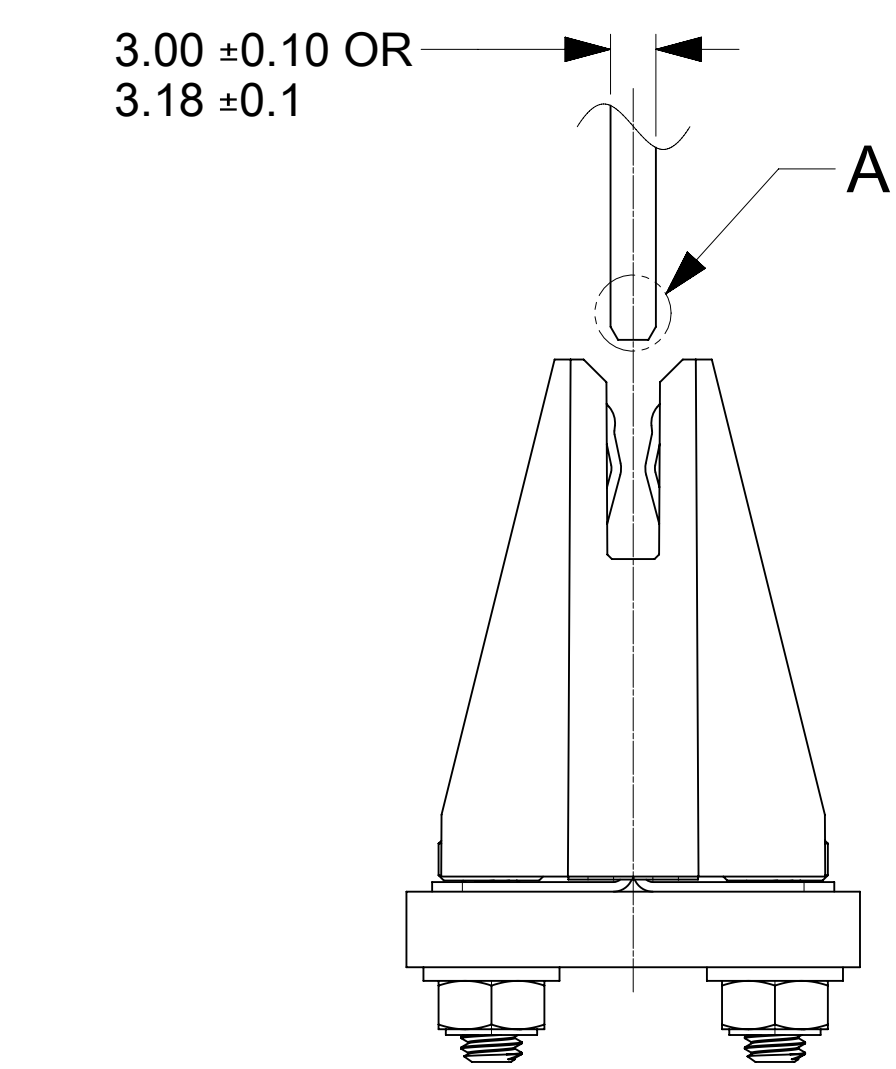

BUSBARS, SCREWS, WASHER AND NUTS
IN THESE VIEWS ARE SHOWN FOR REFERENCE

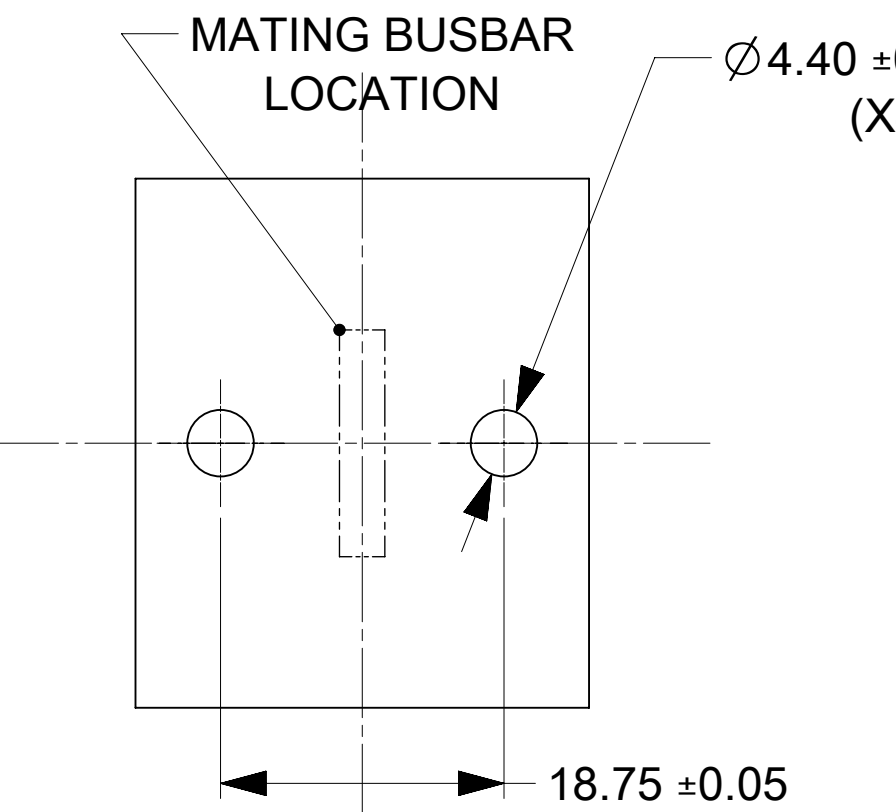


RECOMMENDED
BUSBAR LAYOUT



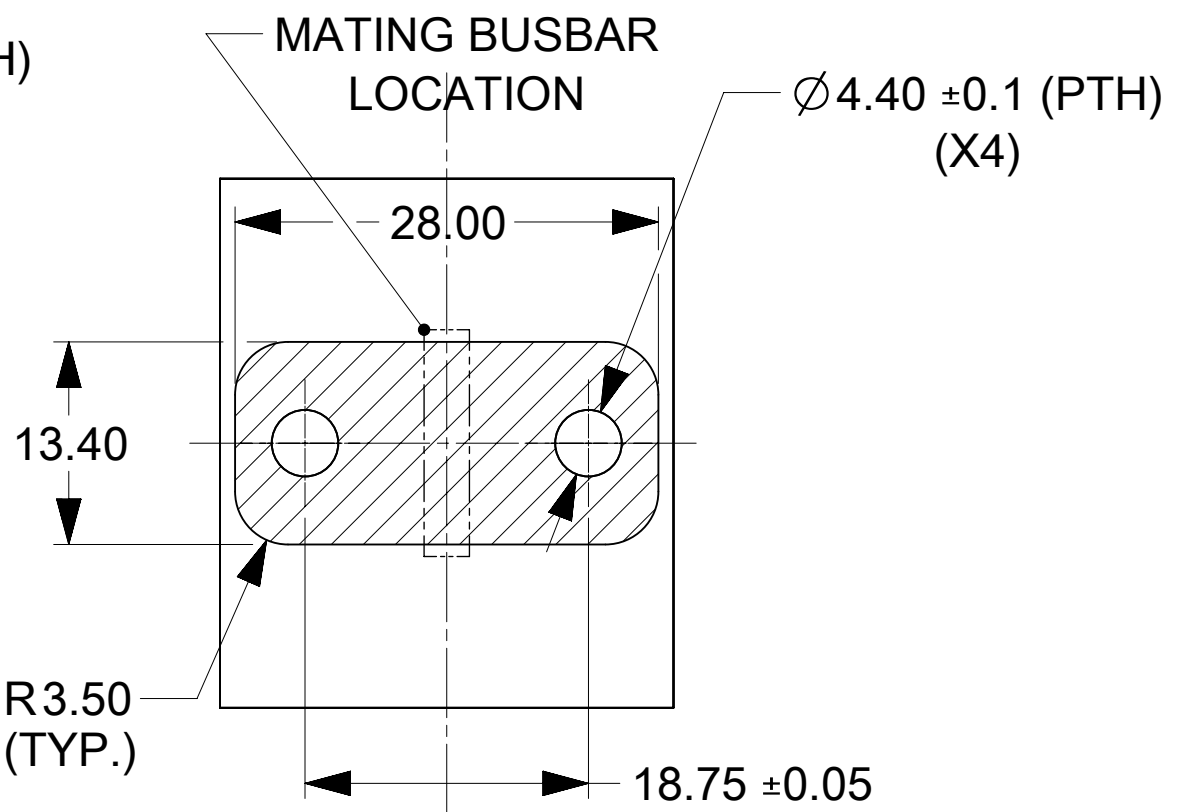


RECOMMENDED
PCB LAYOUT


- NOTES:
- MATERIALS:
 - HOUSING BODY: POLYMER, UL94V-0, BLACK.
 - TERMINALS: COPPER ALLOY.
 - RIVET/CLIP: COPPER ALLOY.
 - PLATING:
 - CONTACT AREAS:
 - OPTION 1: 3.18 MICRON MIN. SILVER, OVER 1.27 MICRON MIN. NICKEL.
 - OPTION 2: 2.50 MICRON MIN. MATTE TIN OV34 1.27 MICRON MIN. NICKEL.
 - TAB AREAS: 3.18 MICRON MIN. SILVER OVER 1.27 MICRON MIN. NICKEL.
 - REST: 1.27 MICRON MIN. NICKEL.
 - LUBRICATION: LUBED IN CONTACT AREA.
 - REFERENCE DOCUMENT:
 - SILVER VERSION: 2132740001-PS, 2132740001-AS.
 - TIN VERSION: 2132740002-PS, 2132740001-AS.
 - MODULE ASSEMBLY IS RoHS COMPLIANT.
 - FINAL ASSEMBLY TO BE PACKAGED AND LABELED PER PACKAGING KIT DRAWING NUMBER 2132740003-PK.

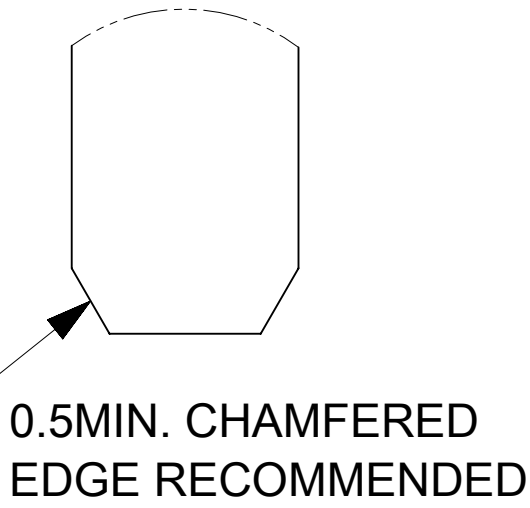

DETAIL A
SCALE 10:1

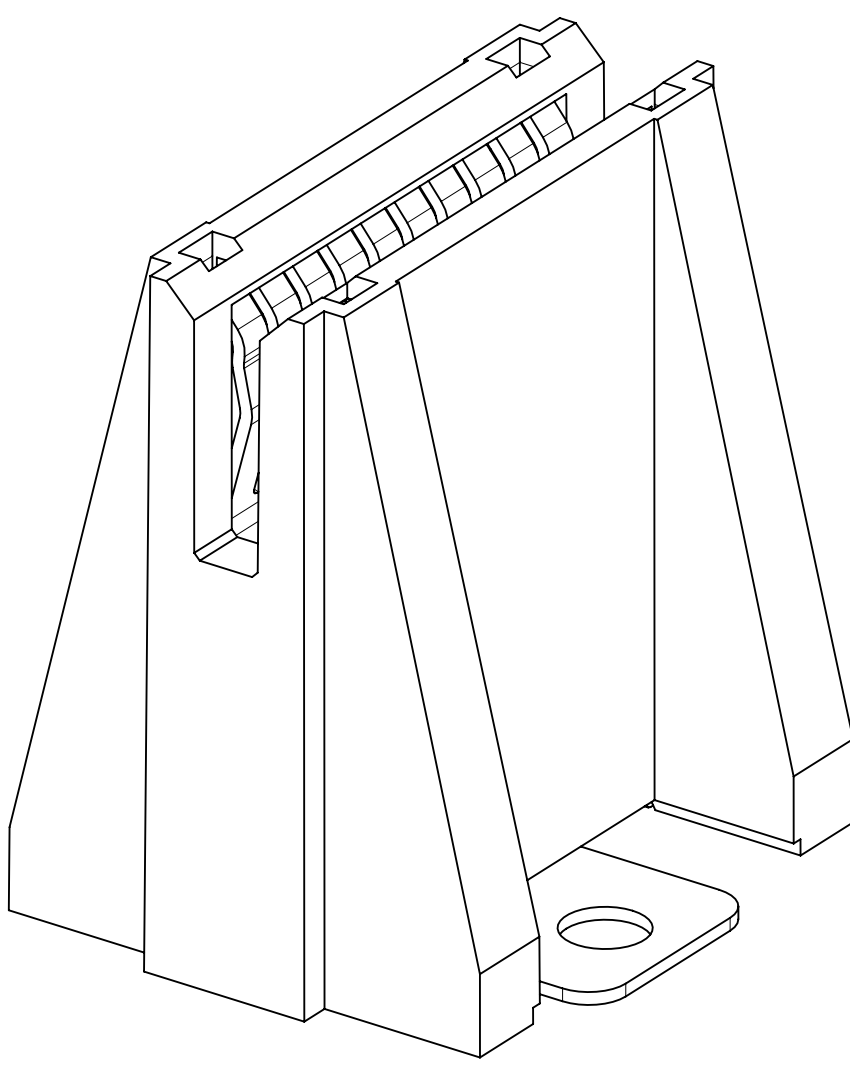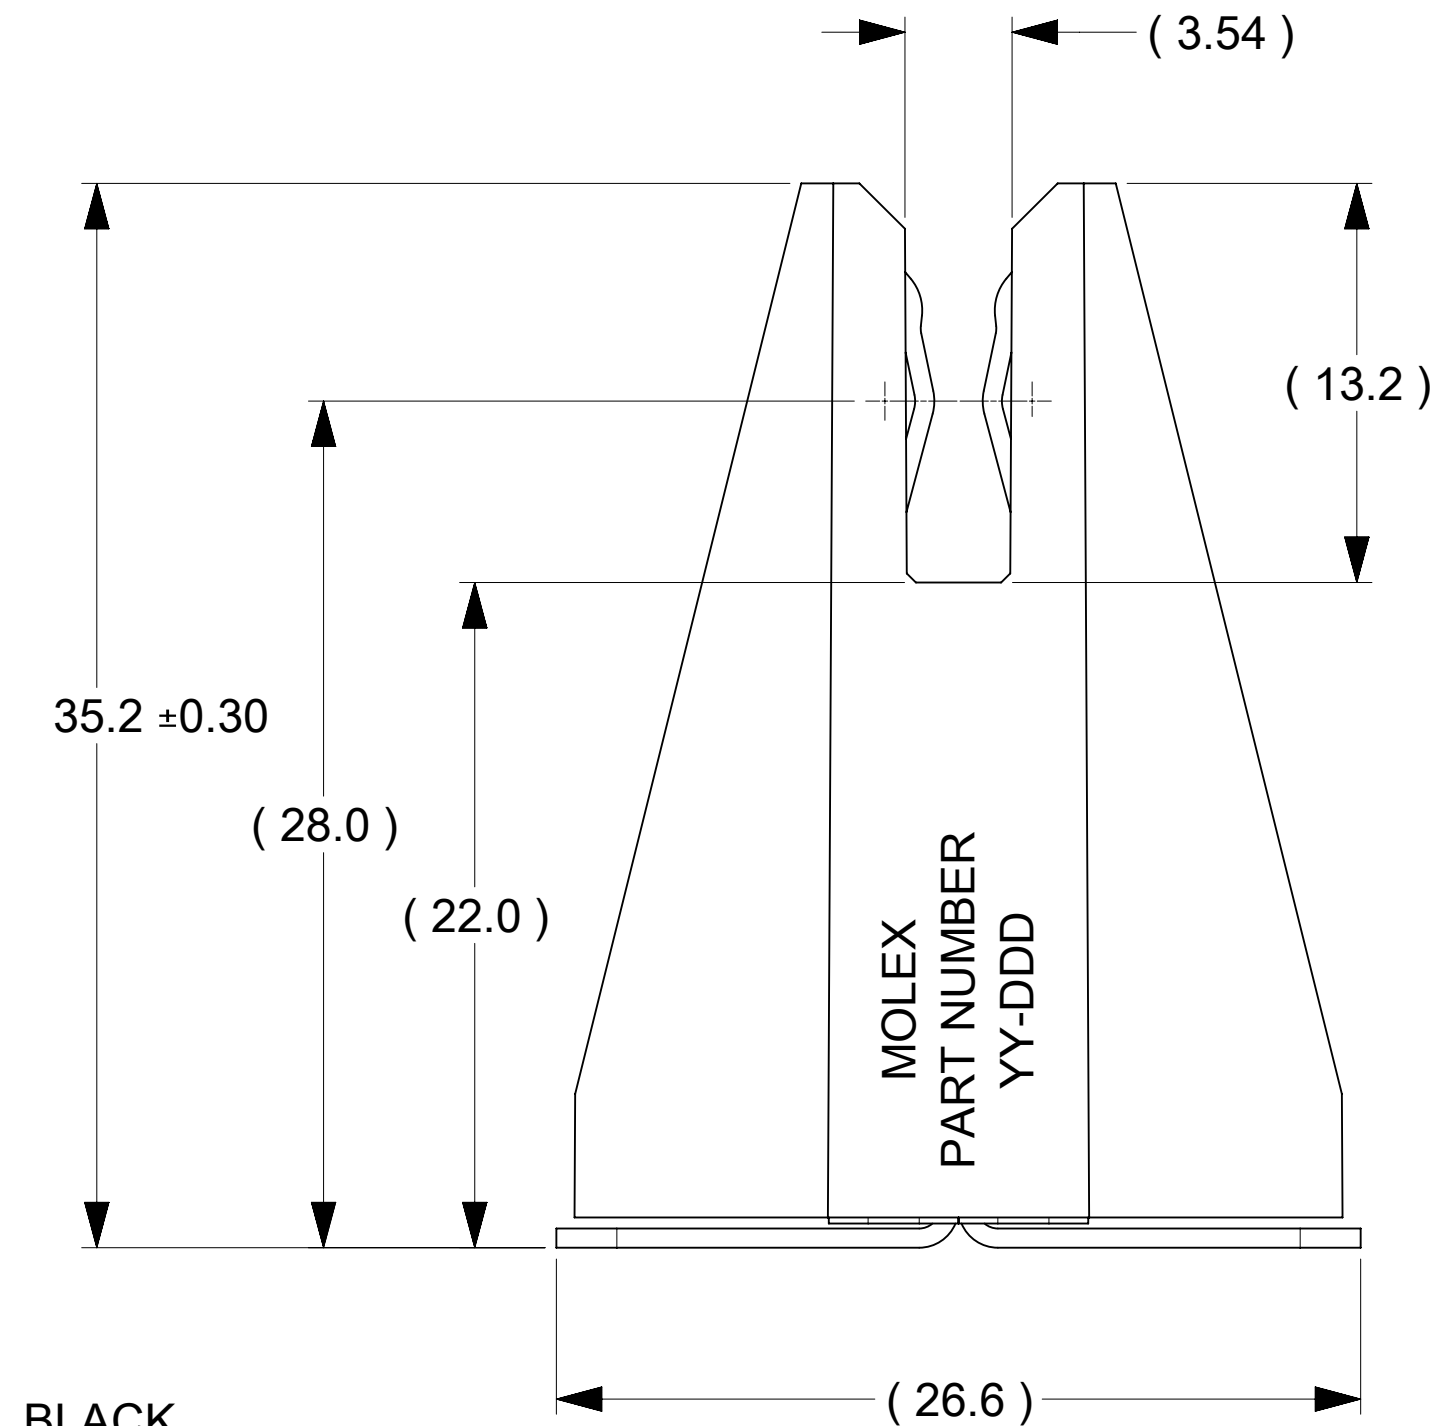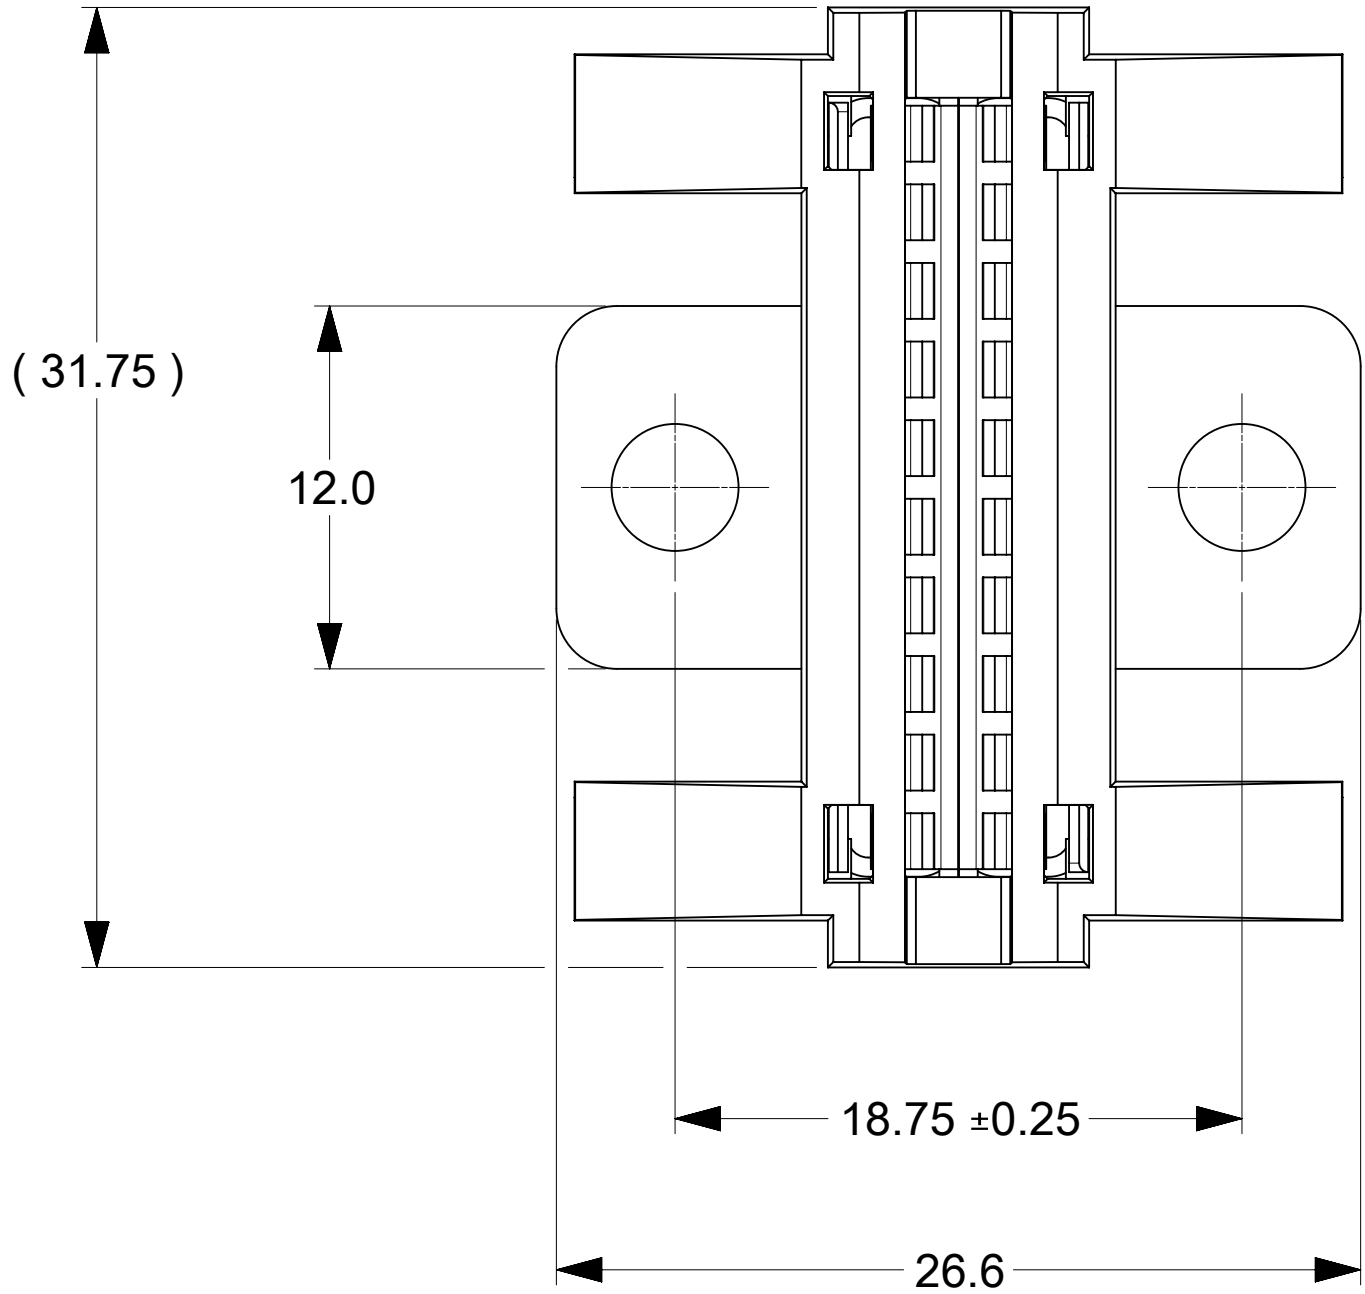

PART NUMBER: 2132740004
(OPEN SIDE WALLS)

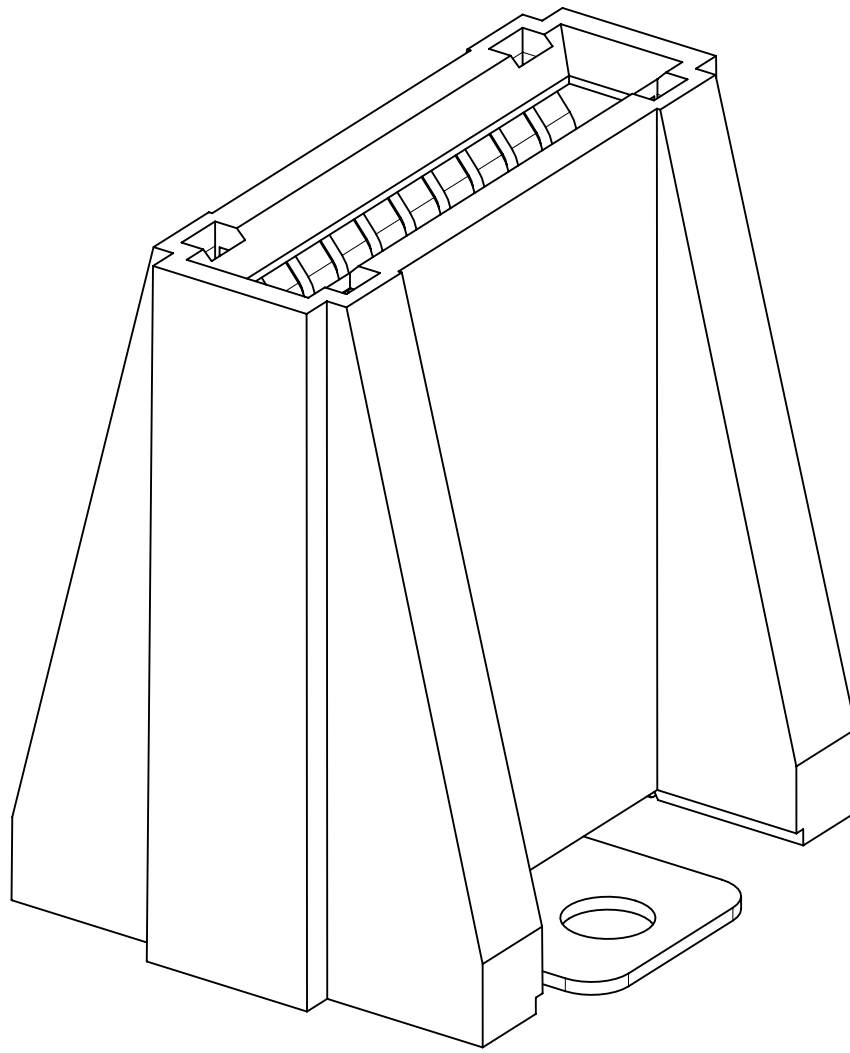

PART NUMBER: 2132741004
(CLOSED SIDE WALLS)

FUNCTIONAL SYMBOLS	THIS DRAWING CONTAINS INFORMATION THAT IS PROPRIETARY TO MOLEX ELECTRONIC TECHNOLOGIES, LLC AND SHOULD NOT BE USED WITHOUT WRITTEN PERMISSION															
A = 0 C = 0 P = 0 DIVISIONAL SYMBOLS	DIMENSION UNITS		SCALE		CURRENT REV DESC:			molex								
	mm		3:1													
	GENERAL TOLERANCES (UNLESS SPECIFIED)					EC NO: 785440 DRWN: JOEJ3 2024/04/23 CHK'D: JAYK1 2024/05/09 APPR: JAYK1 2024/05/09			POWER PLANE BBC 10C VERTICAL_SINGLE HOLE							
	ANGULAR TOL ± °															
	4 PLACES		±													
	3 PLACES		±													
	2 PLACES		± 0.15													
	1 PLACE		± 0.25													
0 PLACES		±														
INITIAL REVISION:					2021/04/07 2021/12/21			PRODUCT CUSTOMER DRAWING								
DRWN: TOMLU																
APPR: BPISZCZOR					DOCUMENT NUMBER			DOC TYPE	DOC PART	REVISION						
DRAFT WHERE APPLICABLE MUST REMAIN WITHIN DIMENSIONS					THIRD ANGLE PROJECTION		DRAWING		SERIES		MATERIAL NUMBER		CUSTOMER		SHEET NUMBER	
							D-SIZE		213274		SEE CHART				1 OF 1	

DOCUMENT STATUS	P1	RELEASE DATE	2024/05/09 15:44:46
-----------------	----	--------------	---------------------