
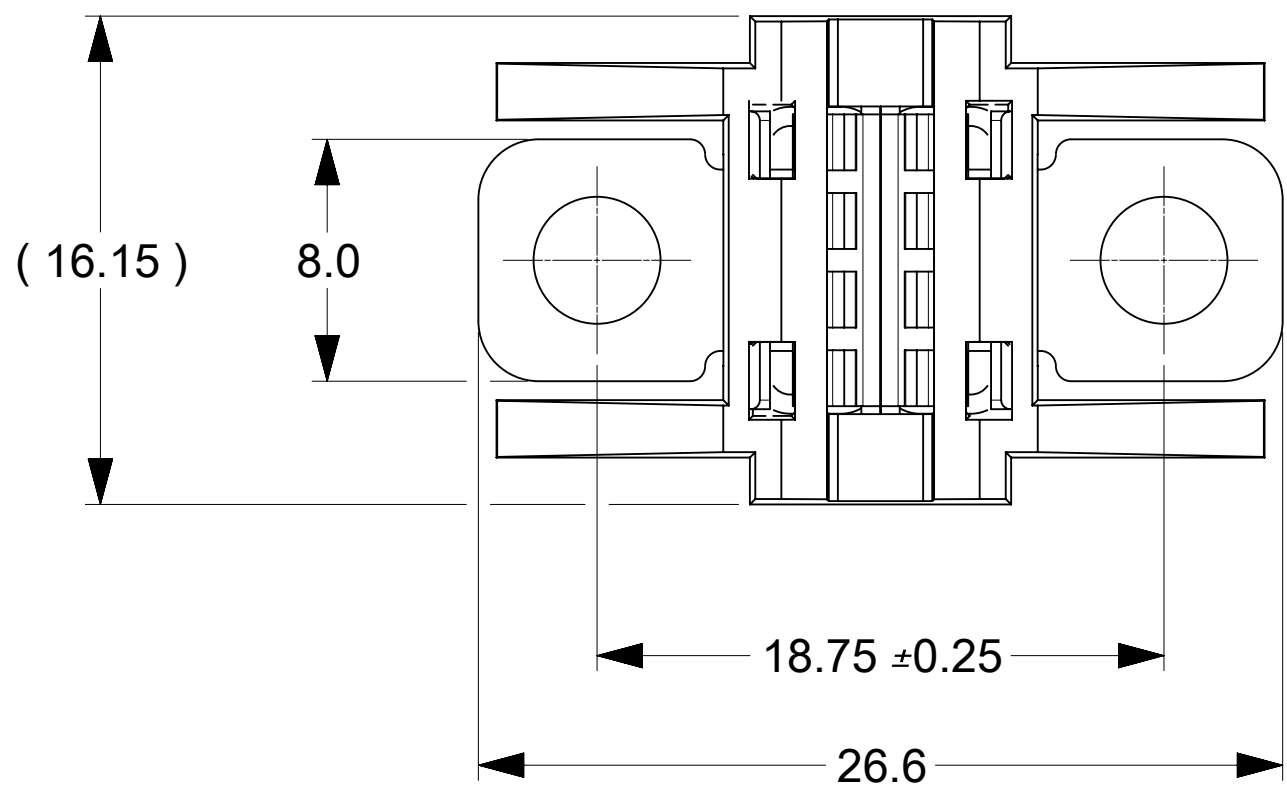
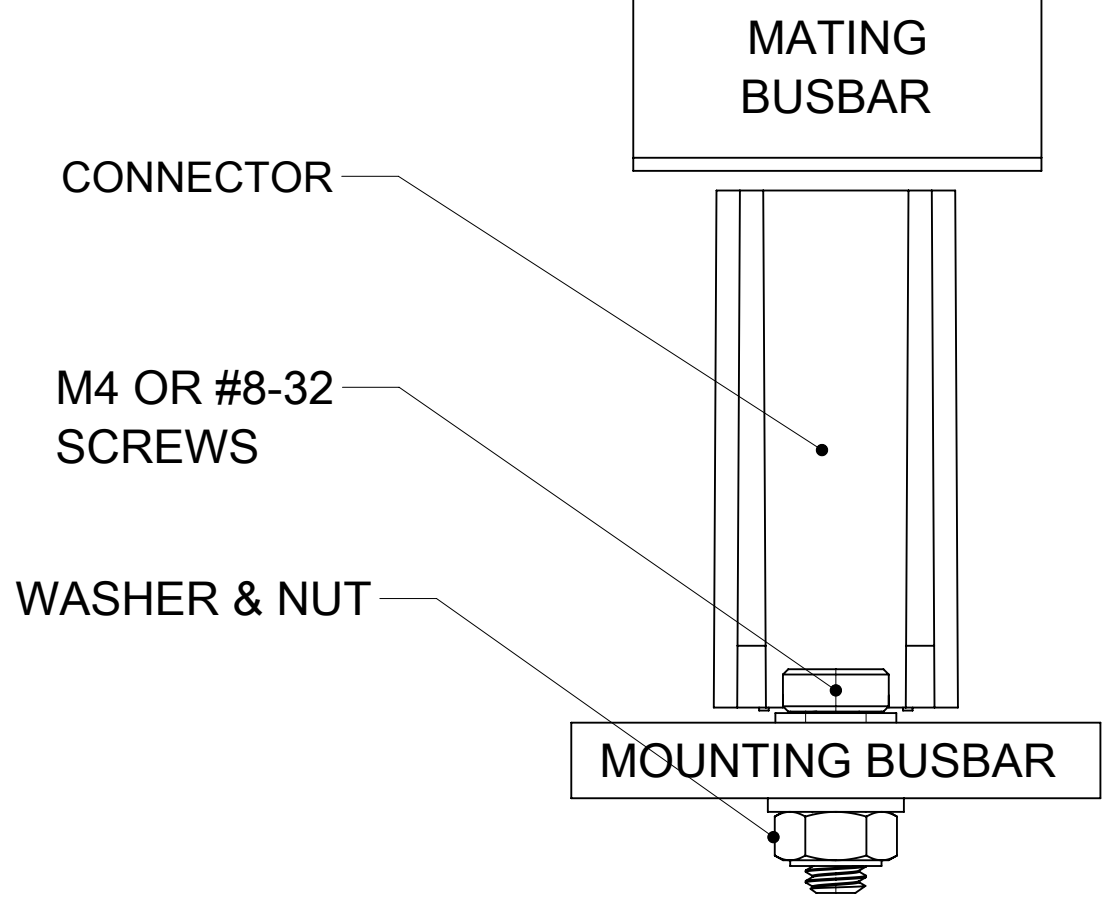



PART NUMBER	DESCRIPTION	NOTE
2132740002	OPEN SIDE WALL (SILVER)	
2132741002	CLOSED SIDE WALL (SILVER)	

PART NUMBER	DESCRIPTION	NOTE
2132740102	OPEN SIDE WALL (TIN)	
2132741102	CLOSED SIDE WALL (TIN)	




>15 (>20 IS PREFERRED; FOR 2132740002)
(OPEN SIDE WALL CONNECTOR)

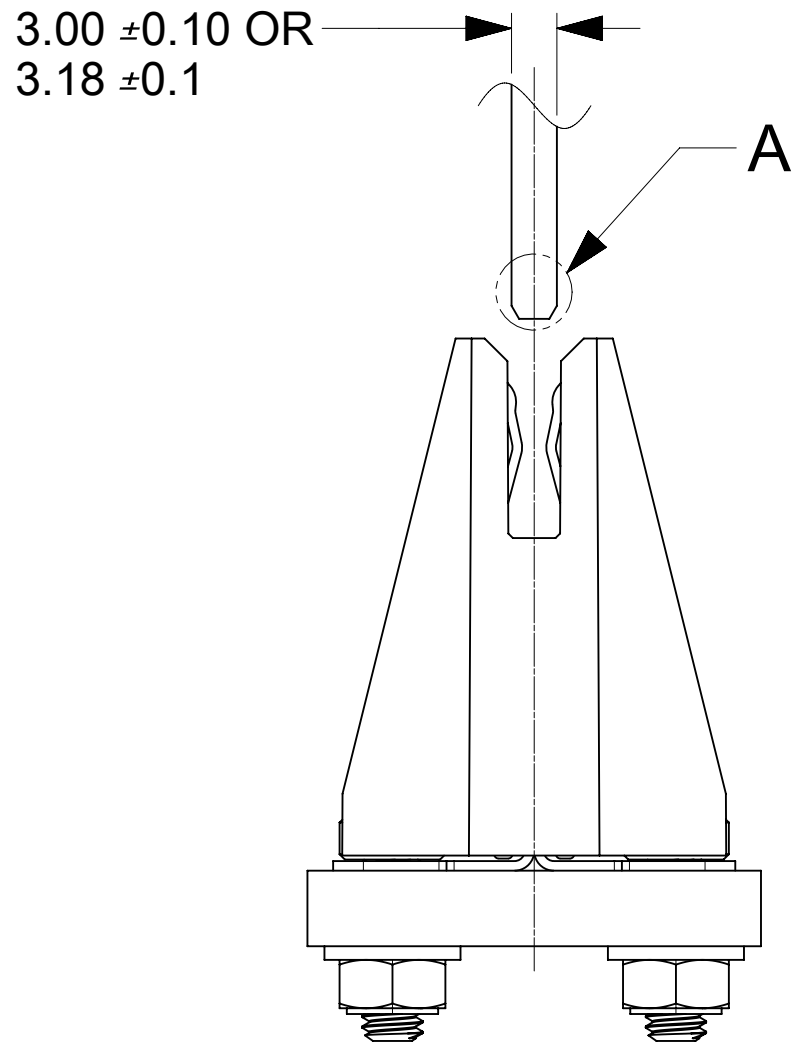

PART NUMBER: 2132740002
(OPEN SIDE WALLS)

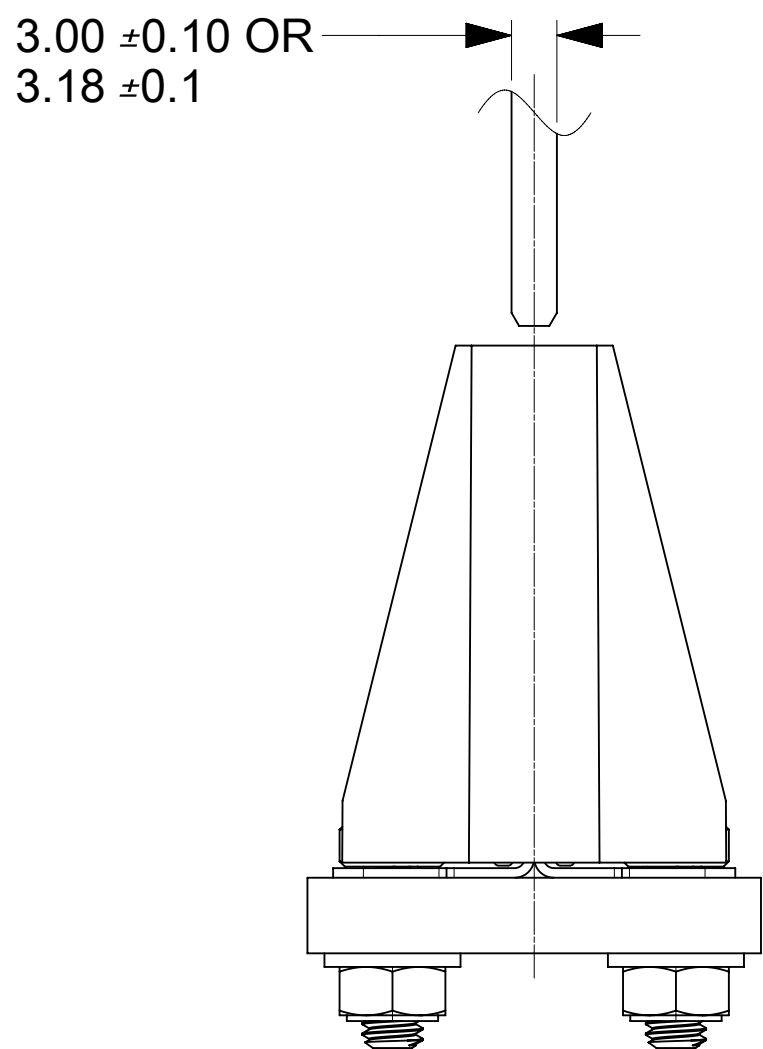


9.5 (FOR 2132741002)
(CLOSED SIDE WALL CONNECTOR)

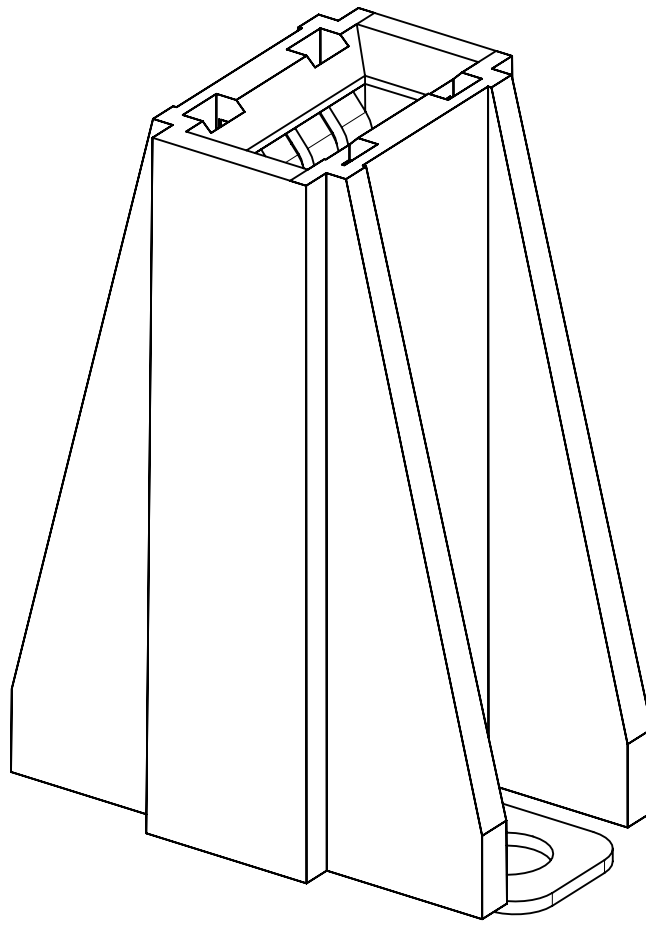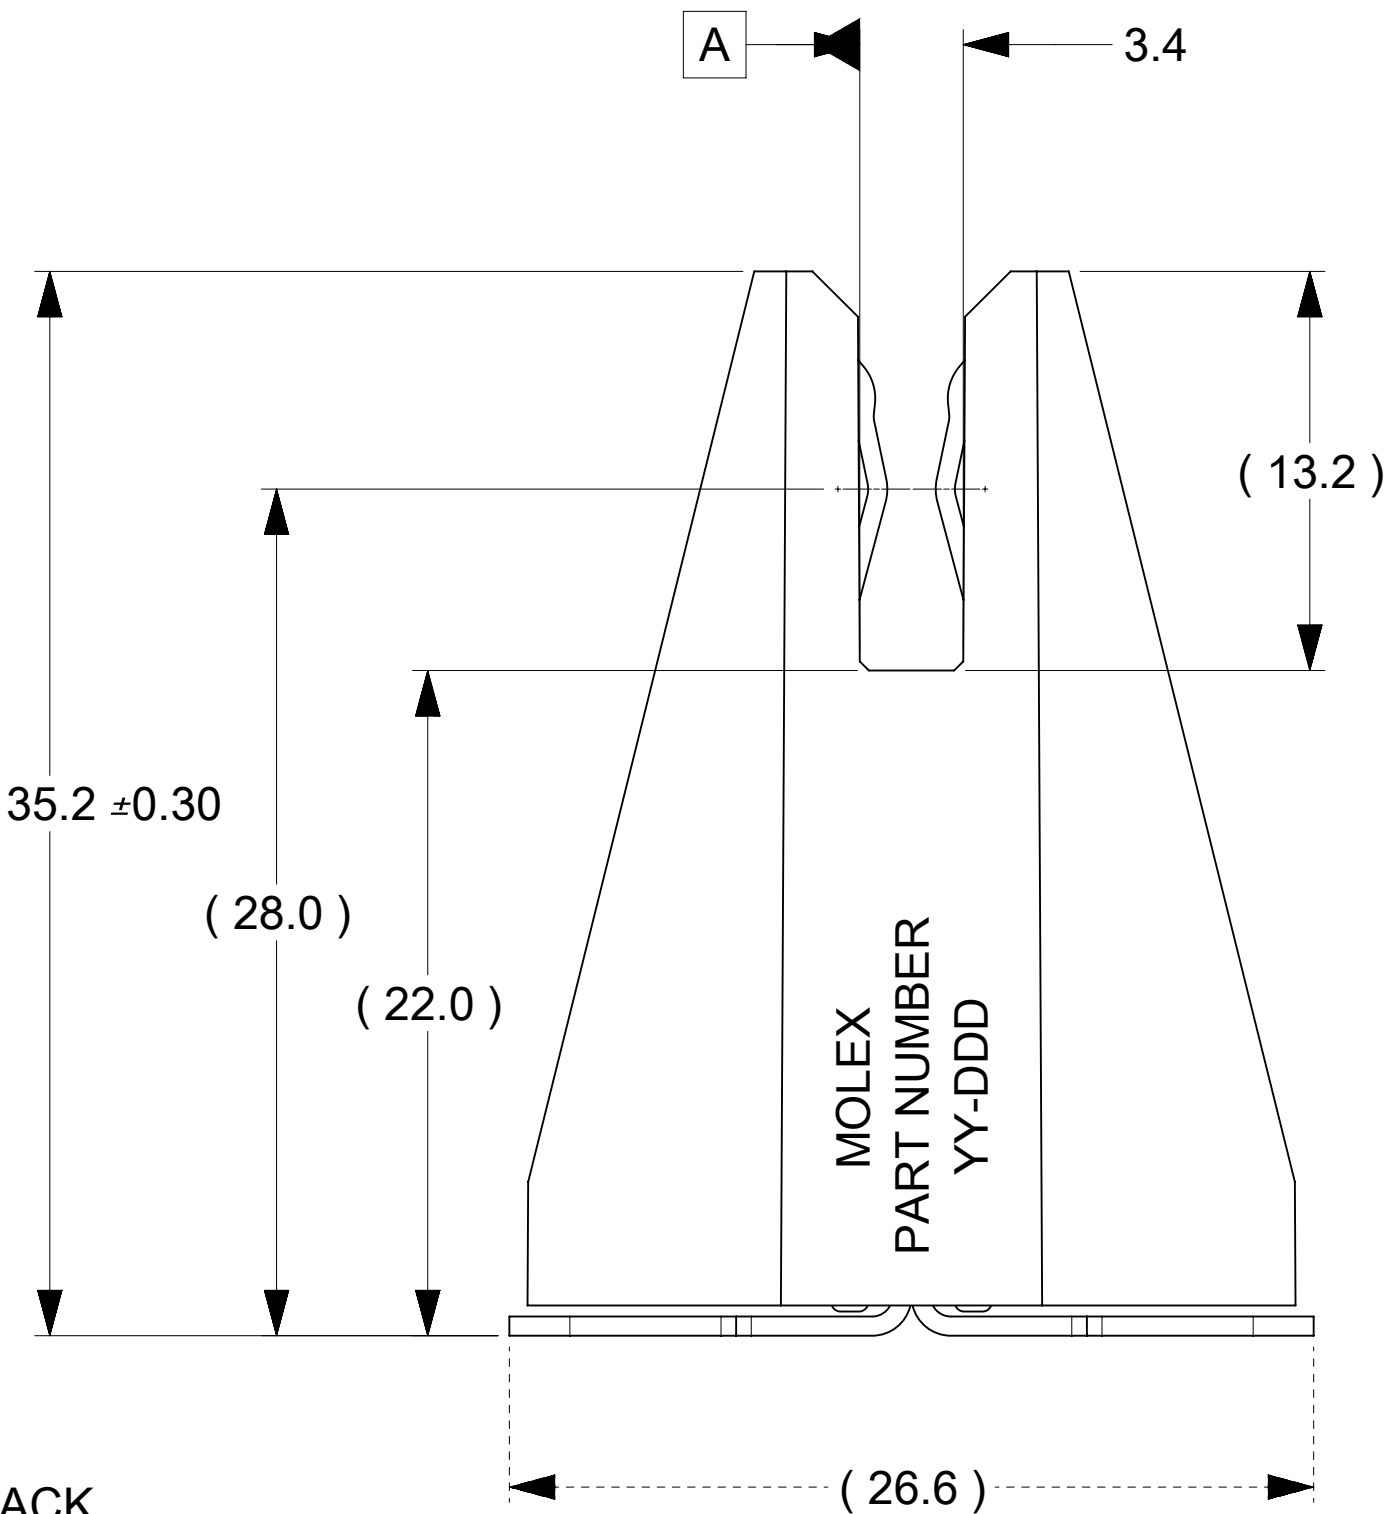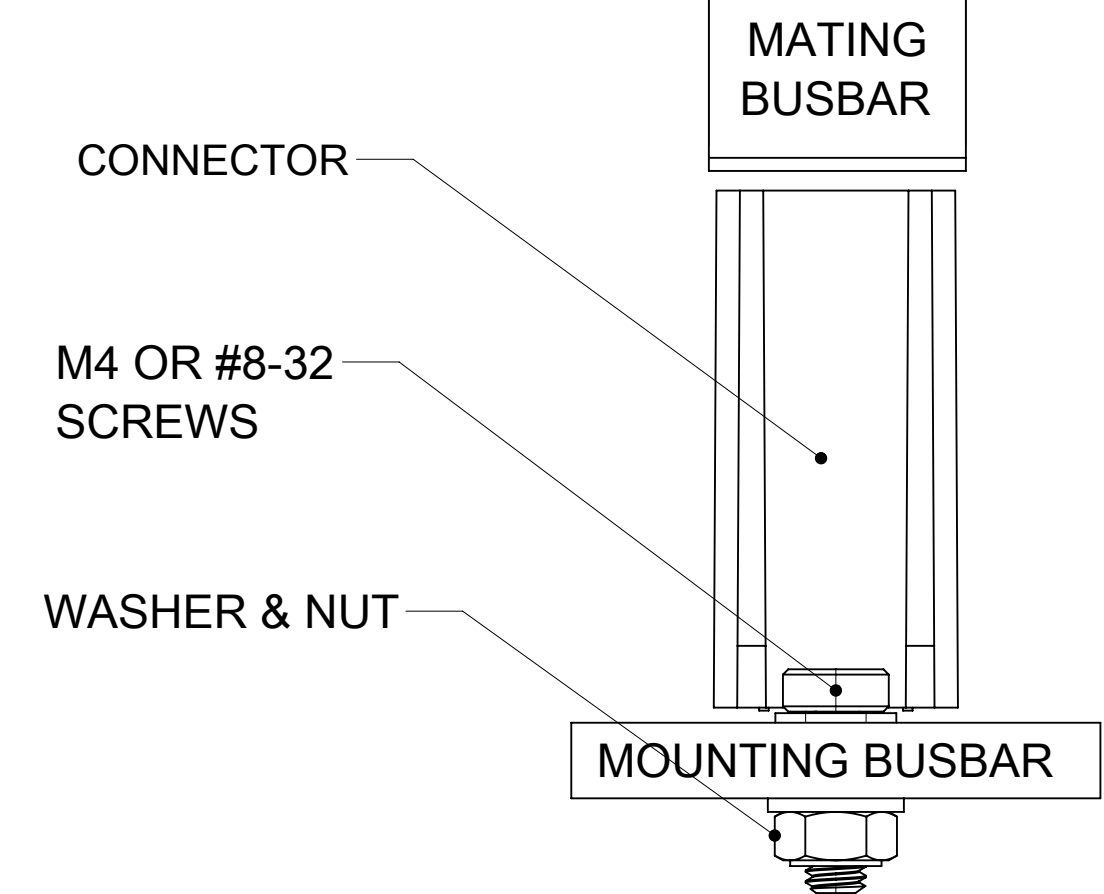


PART NUMBER: 2132741002
(CLOSED SIDE WALLS)


BUSBARS, SCREWS, WASHER AND NUTS
IN THESE VIEWS ARE SHOWN FOR REFERENCE

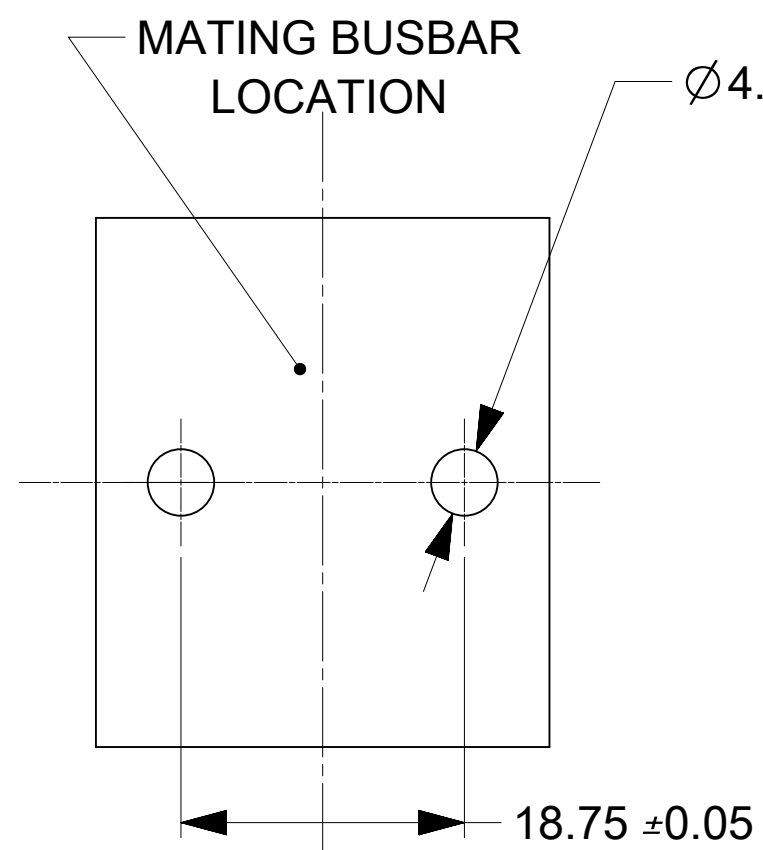

RECOMMENDED
BUSBAR LAYOUT

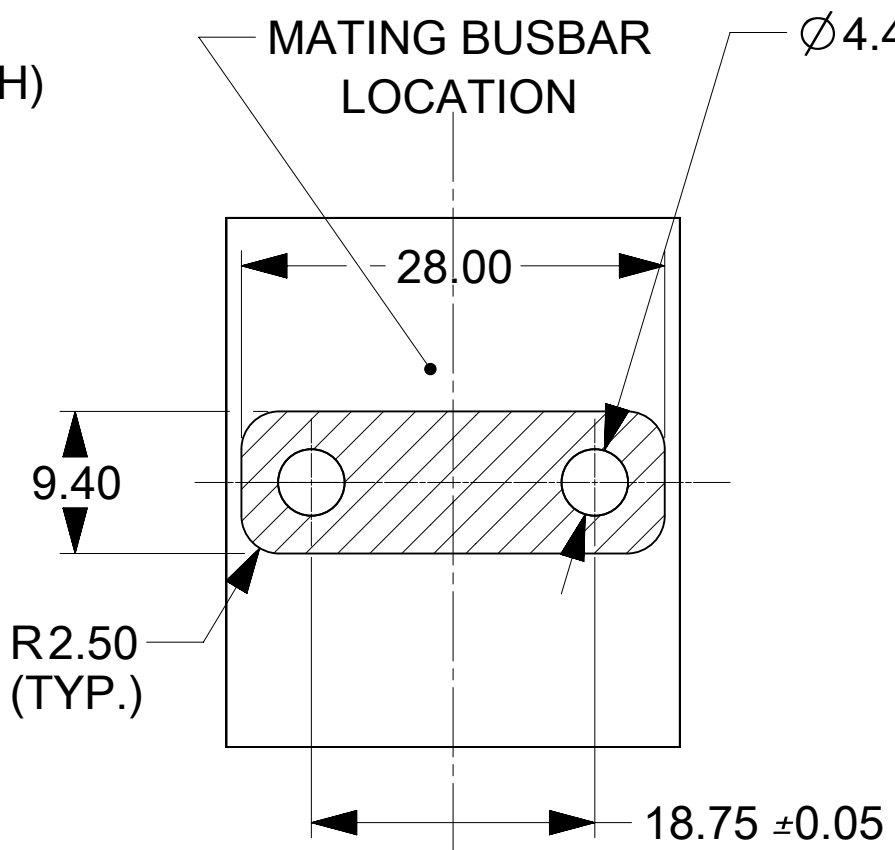

RECOMMENDED
PCB LAYOUT

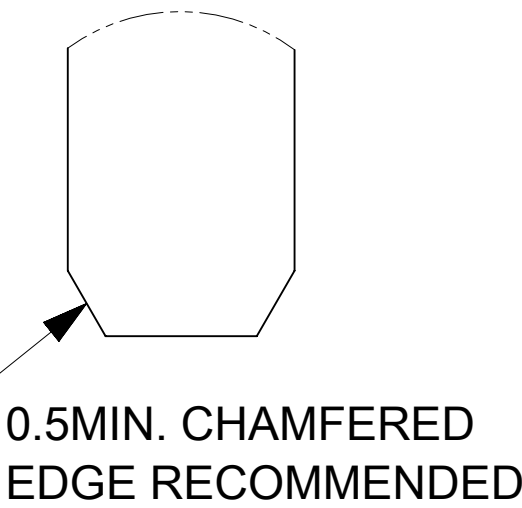

- NOTES:
1. MATERIALS:
- a. HOUSING BODY: POLYMER, UL94V-0, BLACK.
 - b. TERMINALS: COPPER ALLOY.
 - c. RIVET/CLIP: COPPER ALLOY.
2. PLATING:
- a. CONTACT AREAS:
 - OPTION 1: 3.18 MICRON MIN. SILVER, OVER 1.27 MICRON MIN. NICKEL.
 - OPTION 2: 2.50 MICRON MIN. MATTE TIN OV34 1.27 MICRON MIN. NICKEL.
 - b. TAB AREAS: 3.18 MICRON MIN. SILVER OVER 1.27 MICRON MIN. NICKEL.
 - c. REST: 1.27 MICRON MIN. NICKEL.
3. LUBRICATION: LUBED IN CONTACT AREA.
4. REFERENCE DOCUMENT:
- a. SILVER VERSION: 2132740001-PS, 2132740001-AS.
 - b. TIN VERSION: 2132740002-PS, 2132740001-AS.
5. MODULE ASSEMBLY IS RoHS COMPLIANT.
6. FINAL ASSEMBLY TO BE PACKAGED AND LABELED PER PACKAGING KIT DRAWING NUMBER 2132740002-PK.

THIS DRAWING CONTAINS INFORMATION THAT IS PROPRIETARY TO MOLEX ELECTRONIC TECHNOLOGIES, LLC AND SHOULD NOT BE USED WITHOUT WRITTEN PERMISSION														
DIMENSION UNITS		SCALE		CURRENT REV DESC:										
mm		3:1												
GENERAL TOLERANCES (UNLESS SPECIFIED)				EC NO: 815761 DRWN: TOMLU2025/03/13 CHK'D: JAYK12025/03/14 APPR: JAYK12025/03/14 INITIAL REVISION: DRWN: TOMLU2021/06/23 APPR: BPISZCZOR2022/03/09										
ANGULAR TOL ± °														
4 PLACES		±												
3 PLACES		±												
2 PLACES		± 0.15												
1 PLACE		± 0.25												
0 PLACES		±												
DRAFT WHERE APPLICABLE MUST REMAIN WITHIN DIMENSIONS				THIRD ANGLE PROJECTION		DRAWING		SERIES		POWER PLANE BBC 4C VERTICAL				
										PRODUCT CUSTOMER DRAWING				
								DOCUMENT NUMBER		DOC TYPE	DOC PART	REVISION		
								2132740002-SD		PSD	000	B2		
DRAFT WHERE APPLICABLE MUST REMAIN WITHIN DIMENSIONS				THIRD ANGLE PROJECTION		DRAWING		SERIES		MATERIAL NUMBER		CUSTOMER		SHEET NUMBER
										SEE CHART				1 OF 1
						D-SIZE		213274						

molex

POWER PLANE BBC 4C VERTICAL

PRODUCT CUSTOMER DRAWING

DOCUMENT NUMBER	DOC TYPE	DOC PART	REVISION
2132740002-SD	PSD	000	B2

DOCUMENT STATUS	P1	RELEASE DATE	2025/03/14	16:34:22
-----------------	----	--------------	------------	----------